

**BNBL**

**Project:**  
**SAMTSE OFFICE BUILDING  
 LIGHTING DESIGN**

All dimensions are in mm unless specified otherwise

**Title:** Electrical Drawing: General Layout

Drawn by:  
**Jamyang Zeopa, Facility Officer  
 (Electrical)**

Checked by:

Approved by:

Scale:  
 NTS


Revision No.:

Drawing No.  
 18.TS.03

Drawn Date:  
 Nov, 2019

Sheet No.  
 S-1

Revision Date:

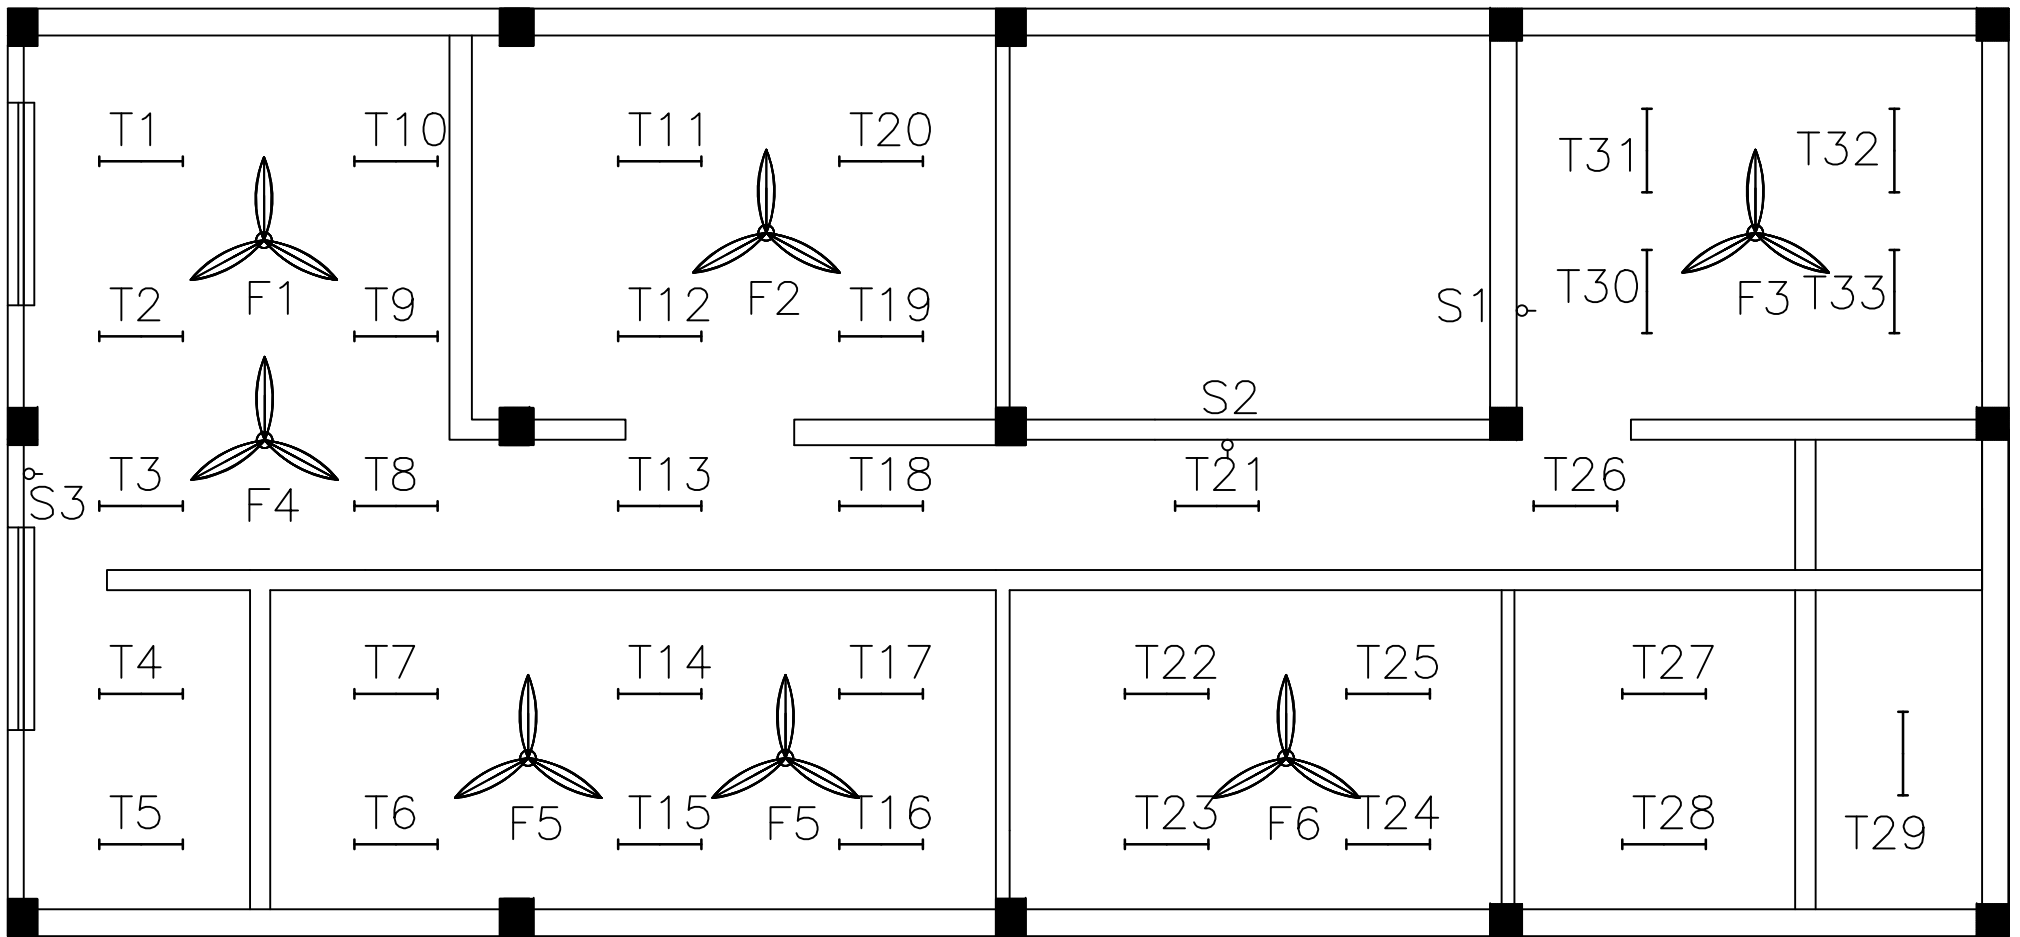

**BNBL**

**Project:**  
**SAMTSE OFFICE BUILDING  
 LIGHTING DESIGN**

All dimensions are in mm unless specified otherwise

**Title:** Electrical Drawing: Lighting Layout

Drawn by:

**Jamyang Zeopa, Facility Officer  
 (Electrical)**

Checked by:

Approved by:

Scale:  
 NTS


Revision No.:

Drawing No.  
 18.TS.03

Drawn Date:  
 Nov, 2019

Sheet No.  
 E-1

Revision Date:

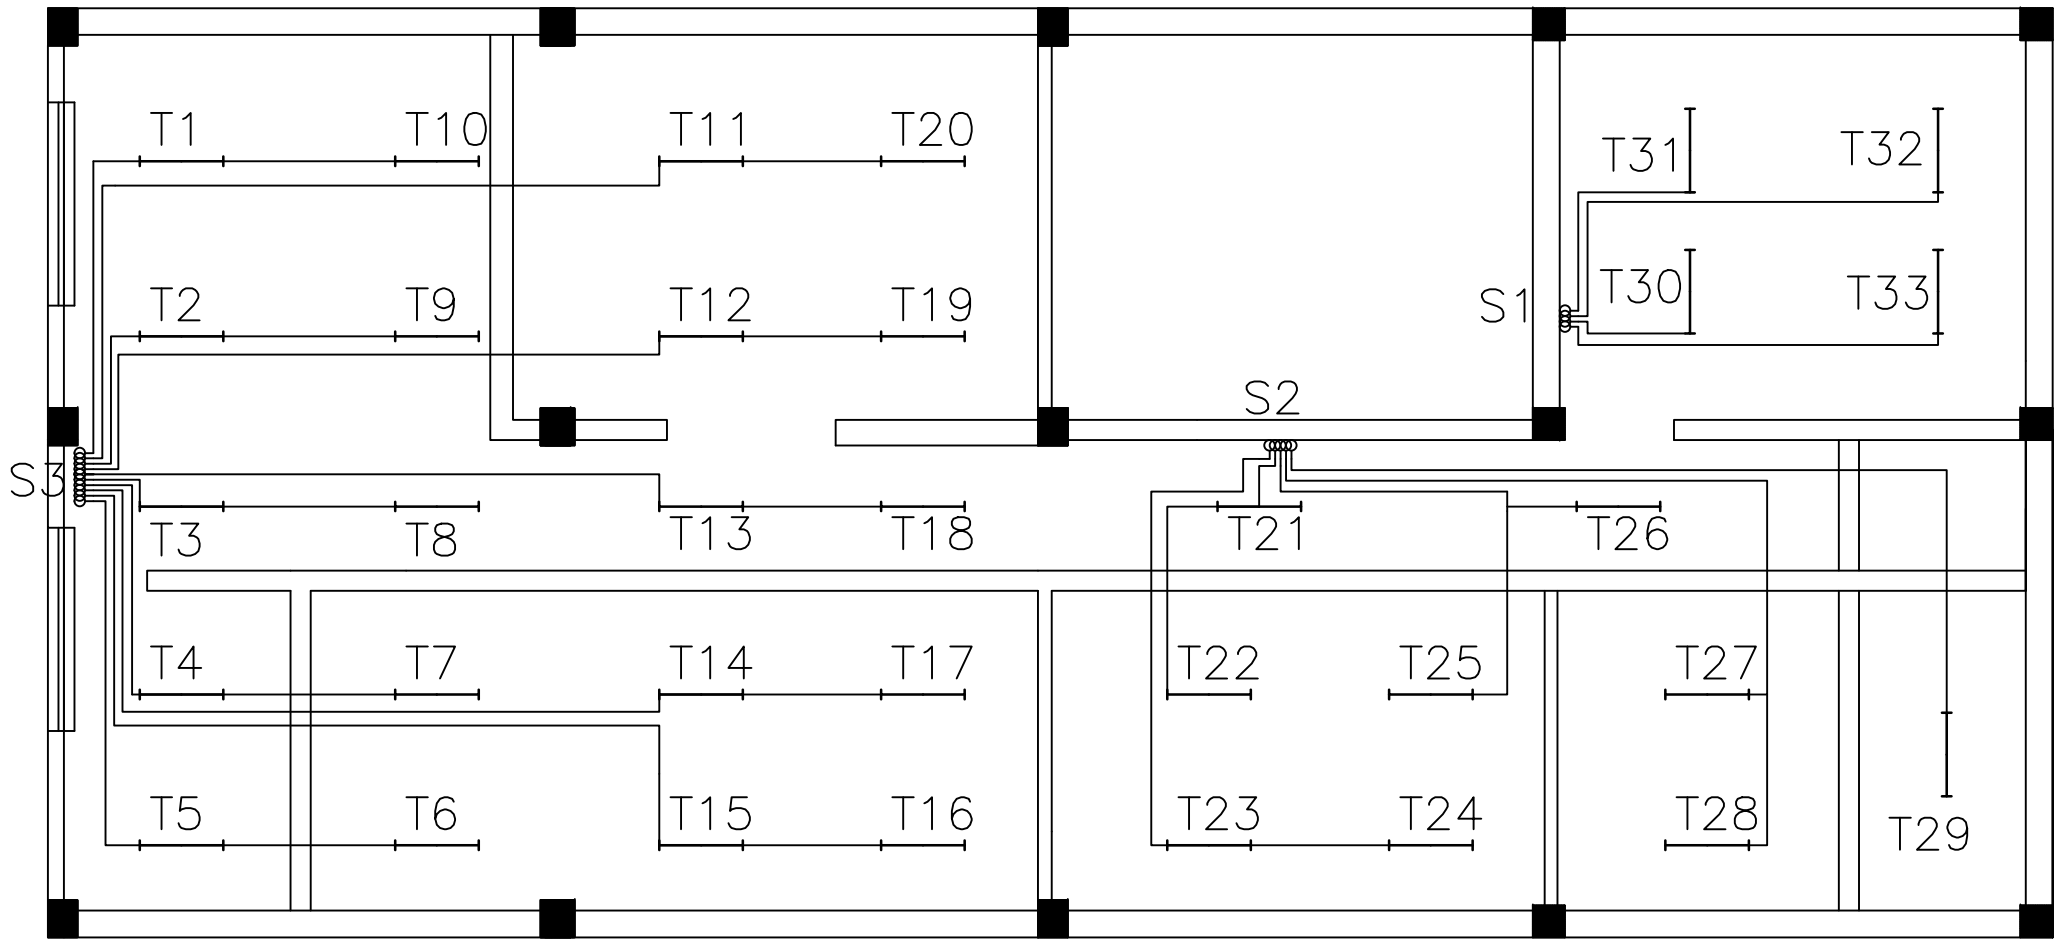

**BNBL**

**Project:**  
SAMTSE OFFICE BUILDING  
LIGHTING DESIGN

All dimensions are in mm unless specified otherwise

**Title:** Electrical Drawing: Wiring Layout for Lights

Drawn by:  
**Jamyang Zeopa, Facility Officer  
(Electrical)**

Checked by:

Approved by:

Scale:  
NTS


Revision No.:

Drawing No.  
18.TS.03


Drawn Date:  
Nov, 2019

Sheet No.  
S-3

Revision Date:

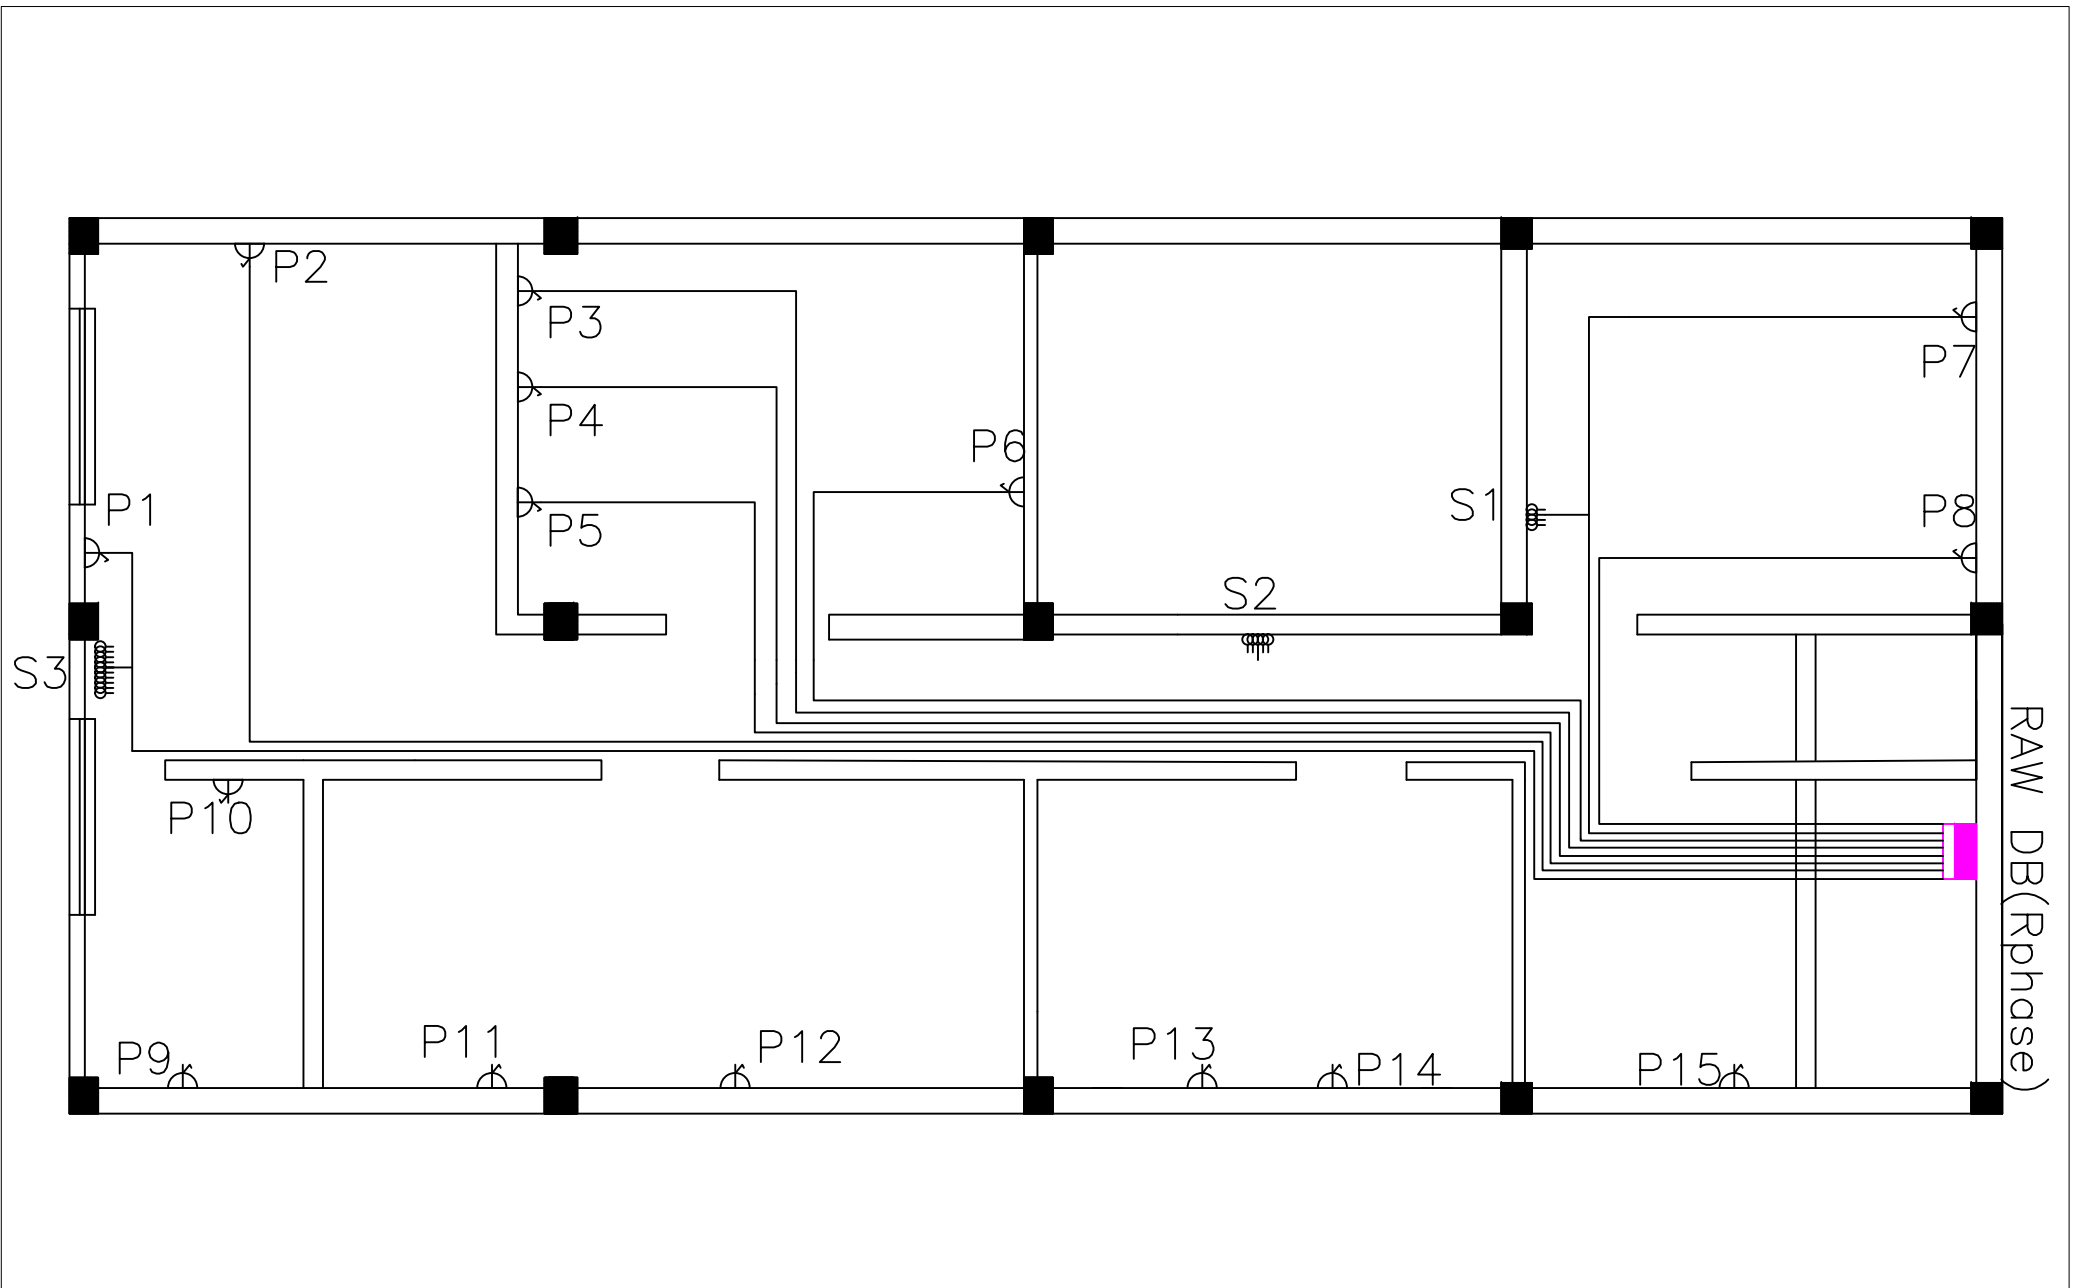

<h1>BNBL</h1>	<b>Project:</b> SAMTSE OFFICE BUILDING LIGHTING DESIGN	<b>Title:</b> Electrical Drawing: Raw Supply Layout			<u>Scale:</u> NTS	<u>Drawing No.:</u> 18.TS.03	<u>Sheet No.:</u> S-4
		<u>Drawn by:</u> <b>Jamyang Zeopa, Facility Officer (Electrical)</b>	<u>Checked by:</u>	<u>Approved by:</u>	<u>Revision No.:</u>	<u>Drawn Date:</u> Nov, 2019	<u>Revision Date:</u>
All dimensions are in mm unless specified otherwise							

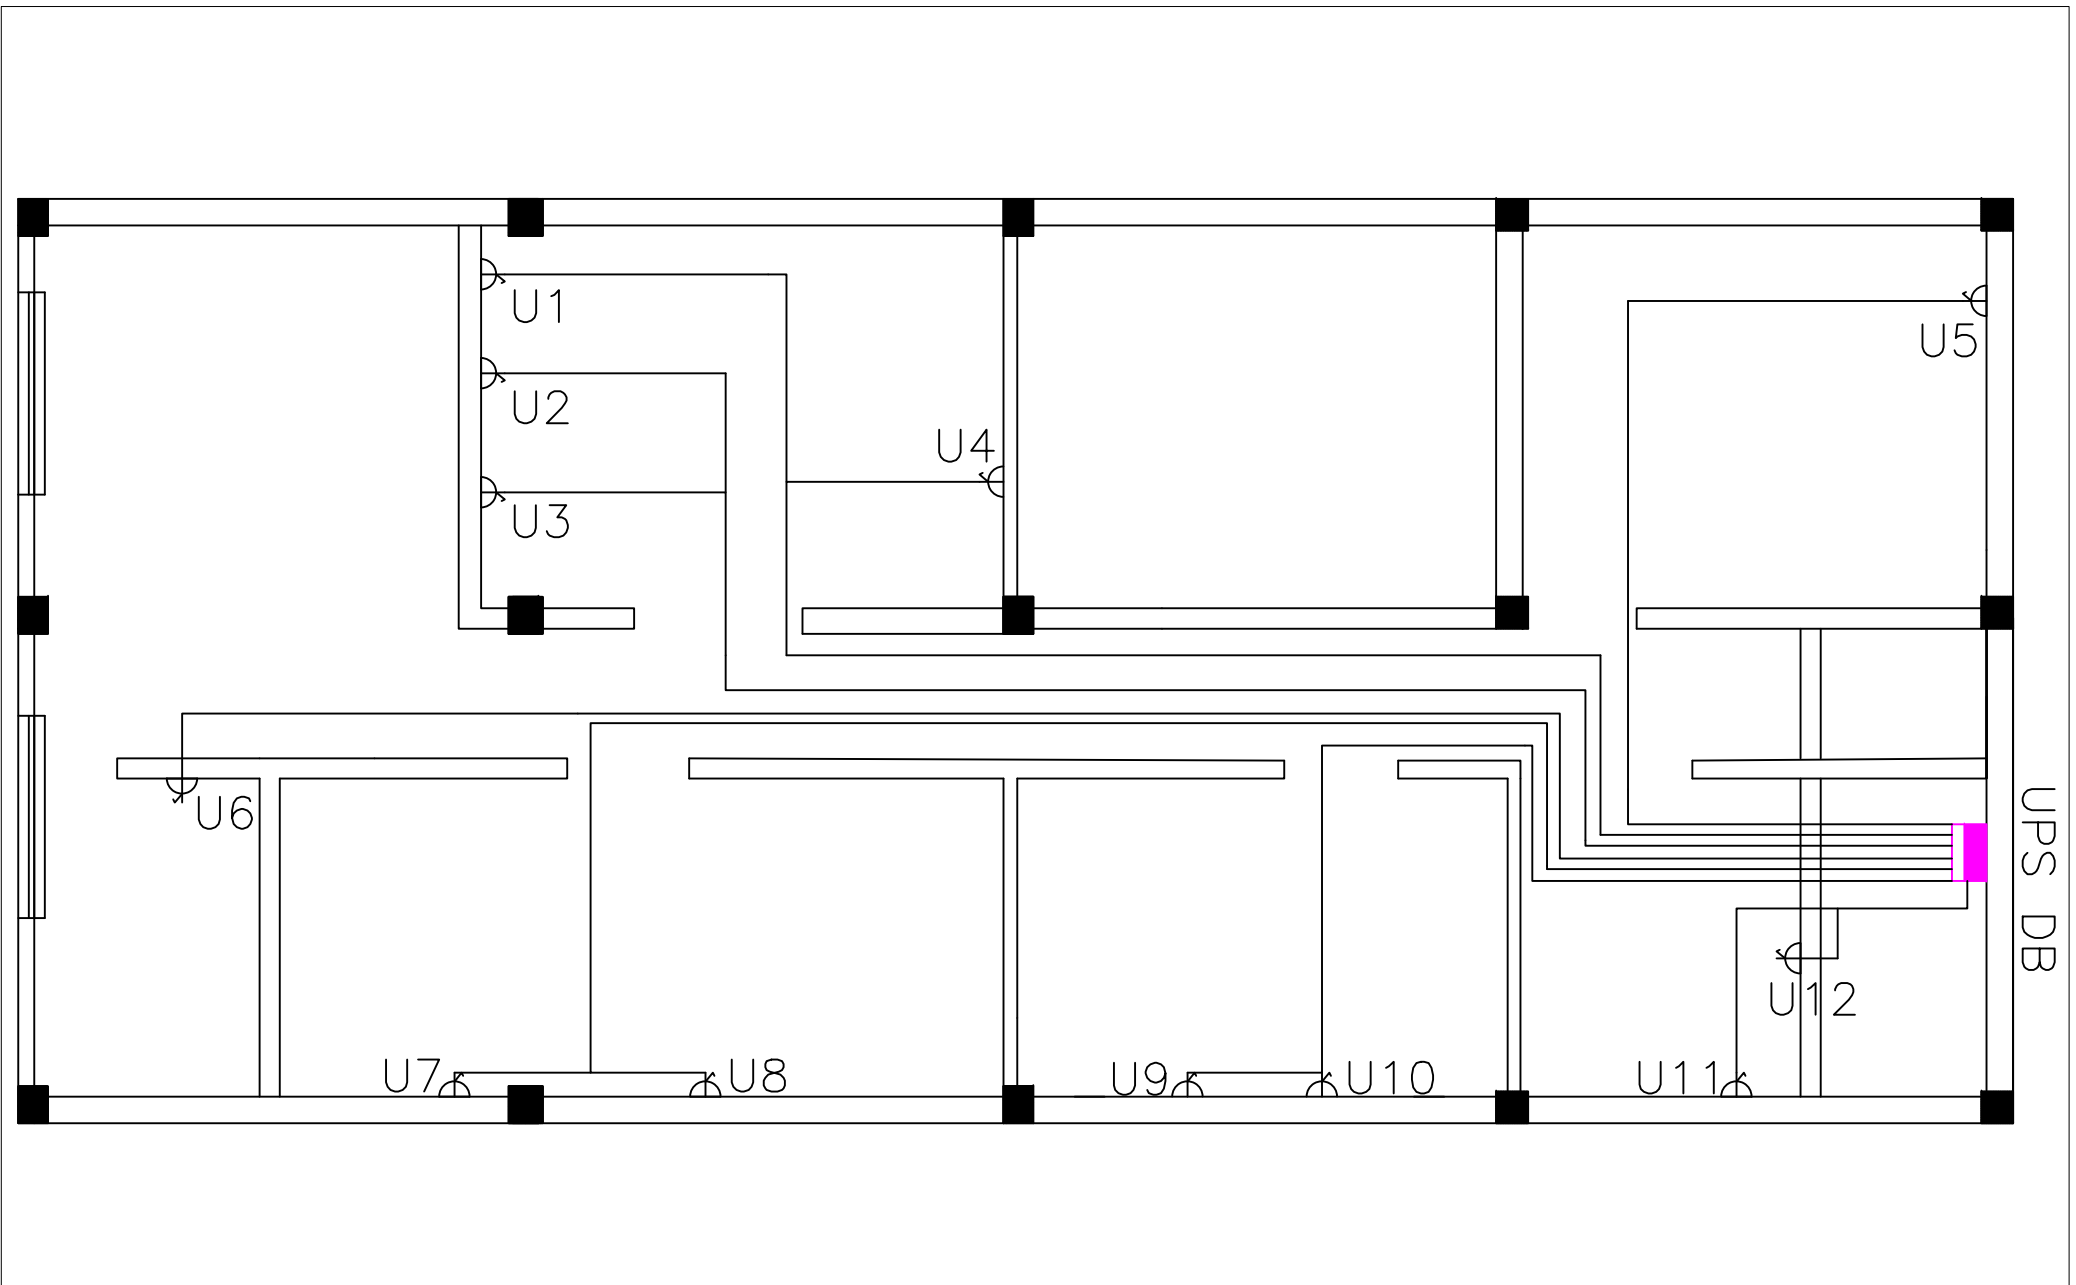

**BNBL**

**Project:**  
 SAMTSE OFFICE BUILDING  
 LIGHTING DESIGN

All dimensions are in mm unless specified otherwise

**Title:** Electrical Drawing: UPS Supply layout

Drawn by:  
 Janyang Zeopa, Facility Officer  
 (Electrical)

Checked by:

Approved by:

Scale:  
 NTS

Revision No.:

Drawing No.  
 18.TS.03

Drawn Date:  
 Nov, 2019

Sheet No.  
 S-5

Revision Date: